

**XYZ SCHOOLS
INDIANAPOLIS, INDIANA**

**EAST WING
GEOTHERMAL HEAT PUMP
HEATING, VENTILATING, AND AIR CONDITIONING UPGRADE**


PREPARED BY

CORPORATE OFFICE

REGIONAL OFFICE



50'

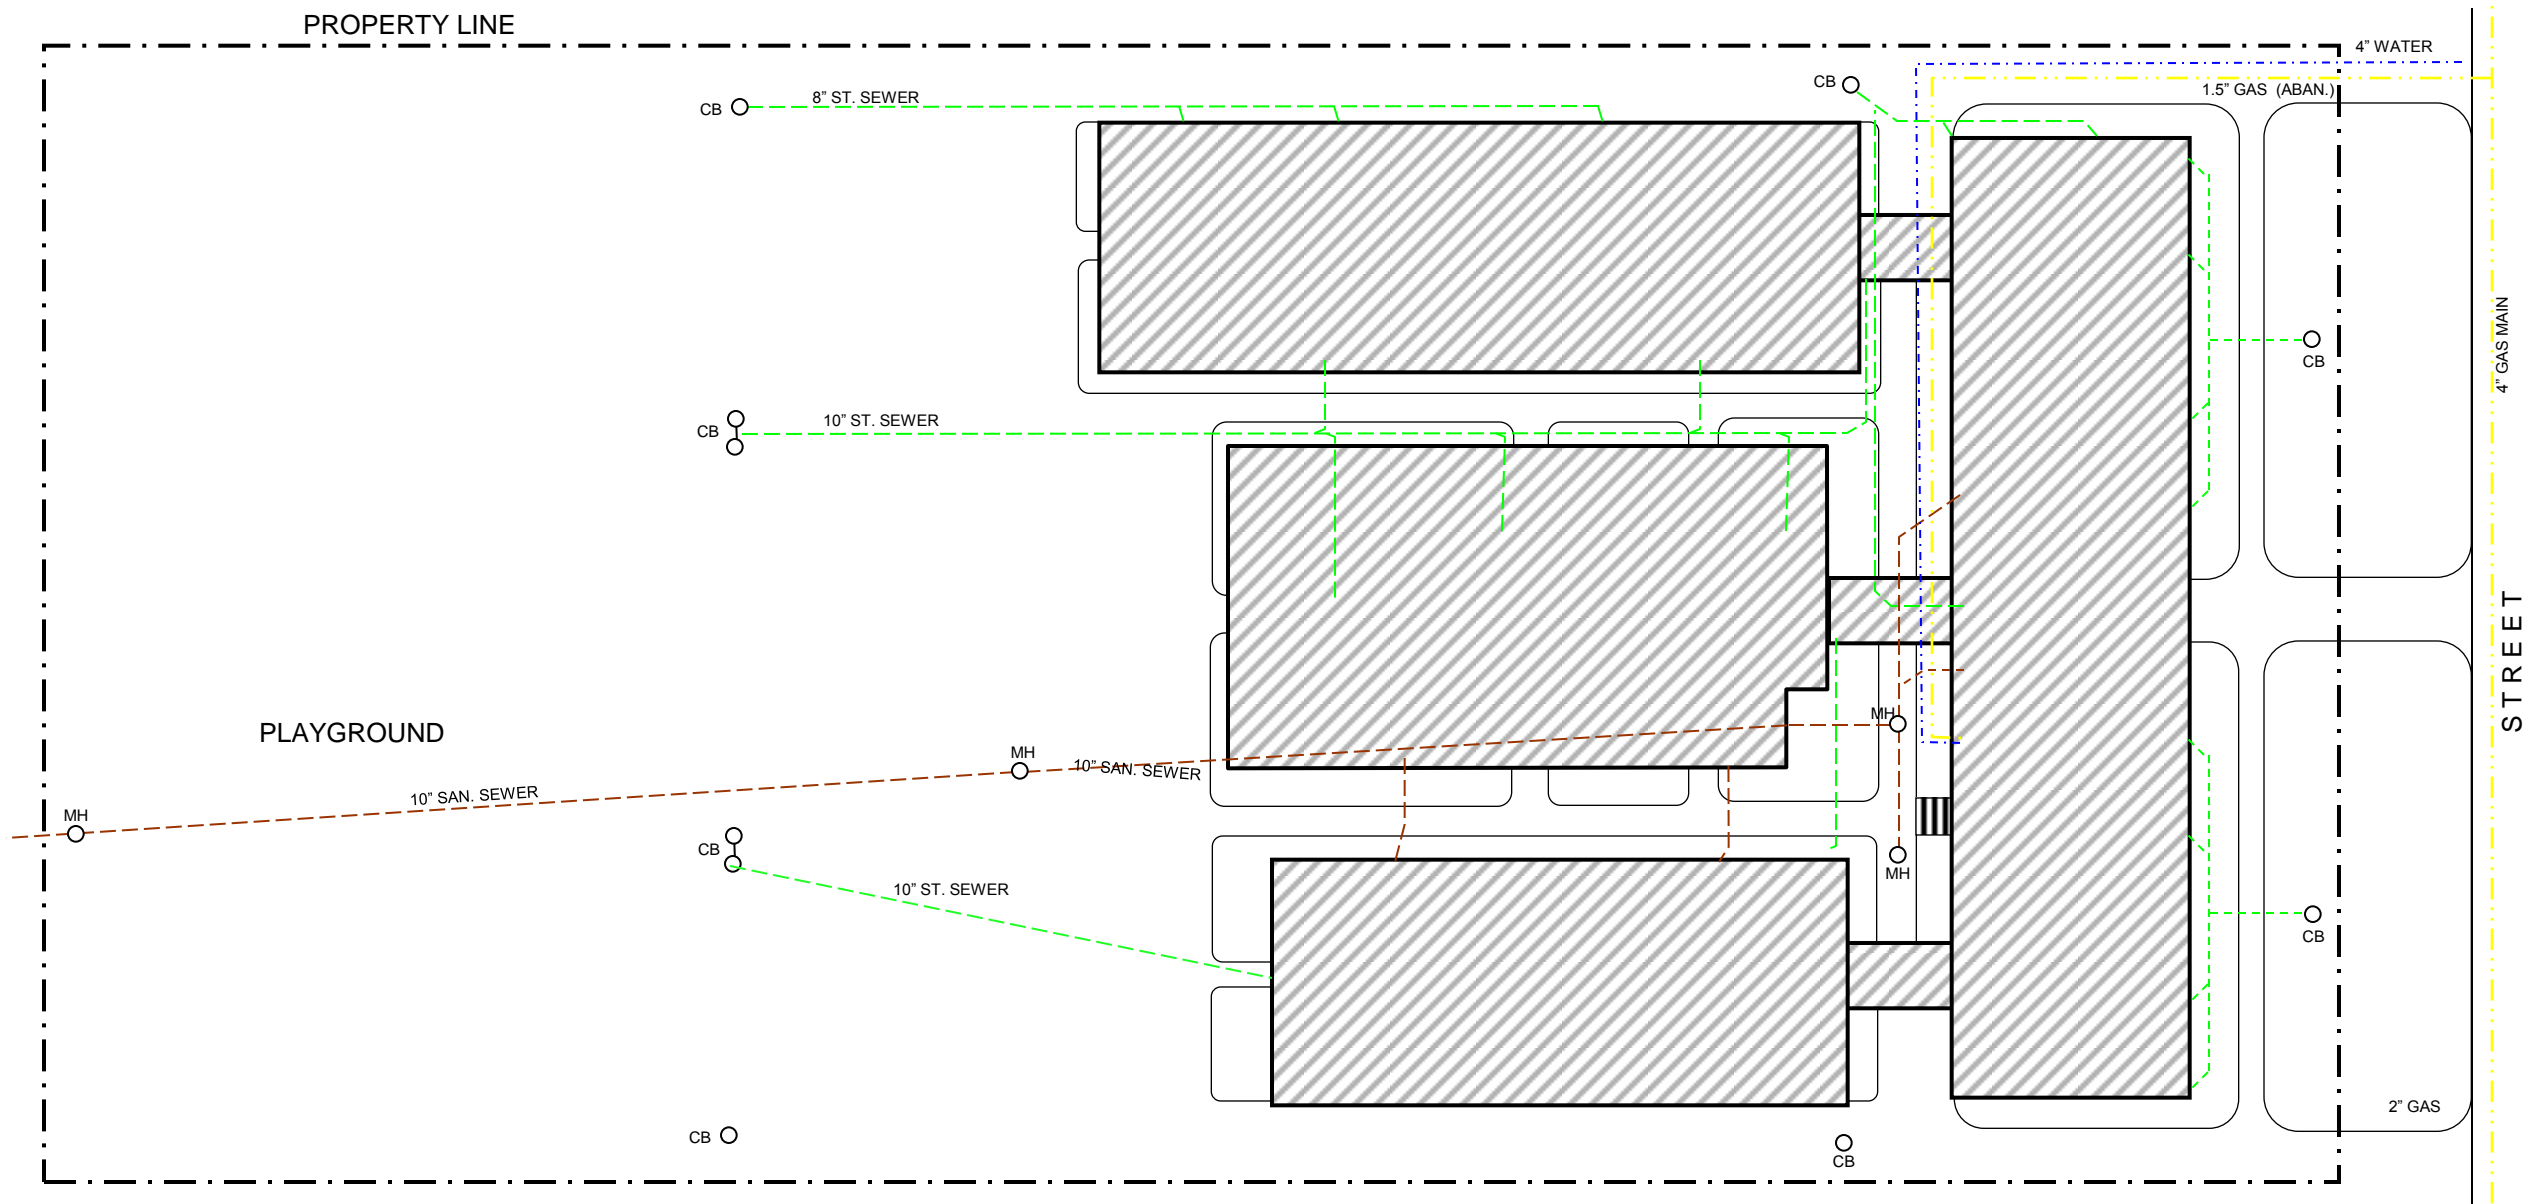



UNDERGROUND UTILITY SYMBOLS:

- NOTE:** VERIFY UTILITY LOCATIONS PRIOR TO UNDERGROUND WORK
- STORM SEWER
 - SANITARY SEWER
 - NATURAL GAS
 - WATER
 - CB CATCH BASIN
 - MH MANHOLE

PROJECT DESIGN & MANAGEMENT:	PROJECT:	SITE PLAN AND UTILITY LOCATIONS	
		DATE:	SCALE: 1" = 50'
			SHEET: M1
		DRN. BY:	CHK. BY:
		SHEET NO.: XX of XX	



20'

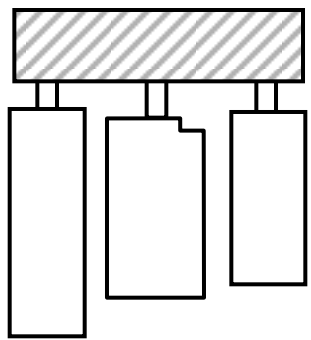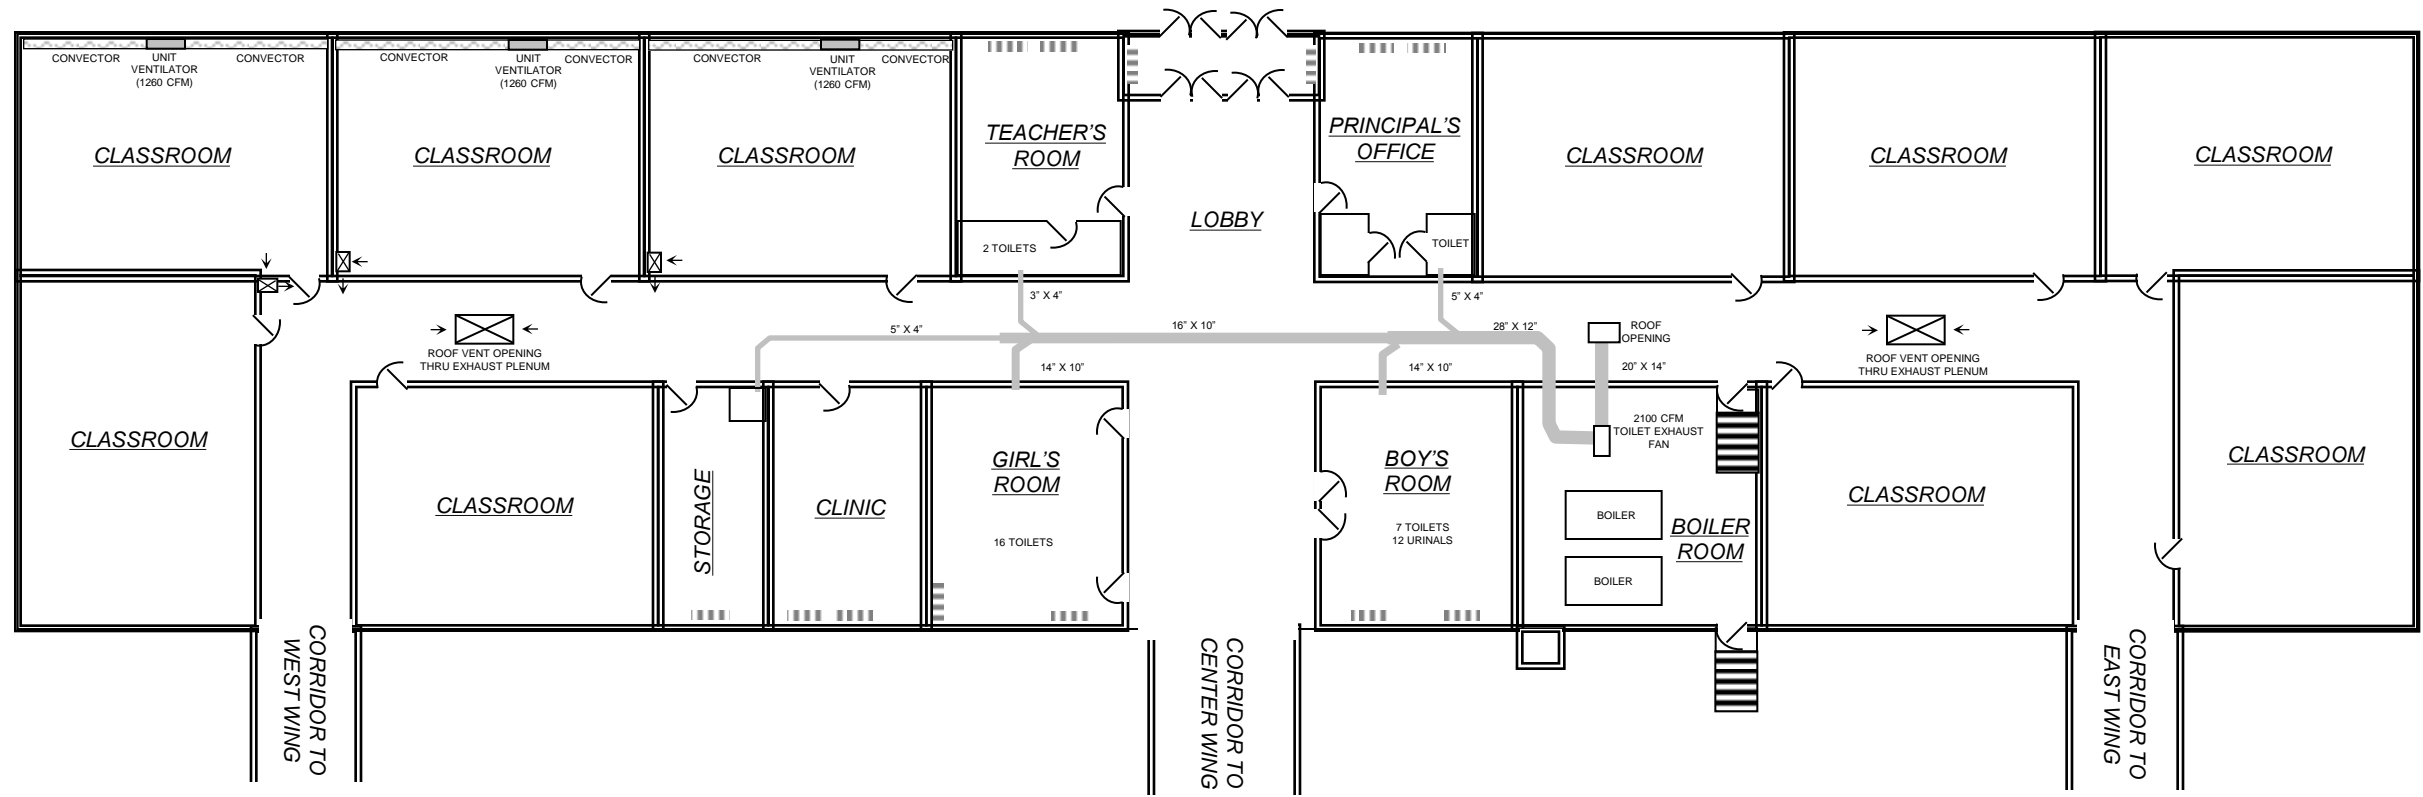


PROJECT DESIGN & MANAGEMENT:

PROJECT:



GEOTHERMAL HVAC UPGRADE
INDIANAPOLIS, IN

EXISTING MECHANICAL PLAN - MAIN WING

DATE:		SCALE: 1" = 20'
		SHEET: M2
DRN. BY:	CHK. BY:	SHEET NO.: XX of XX

 

20'

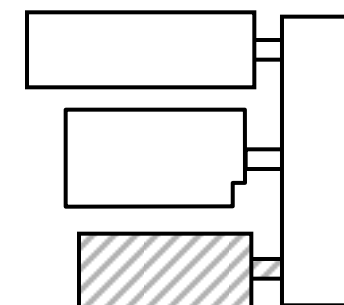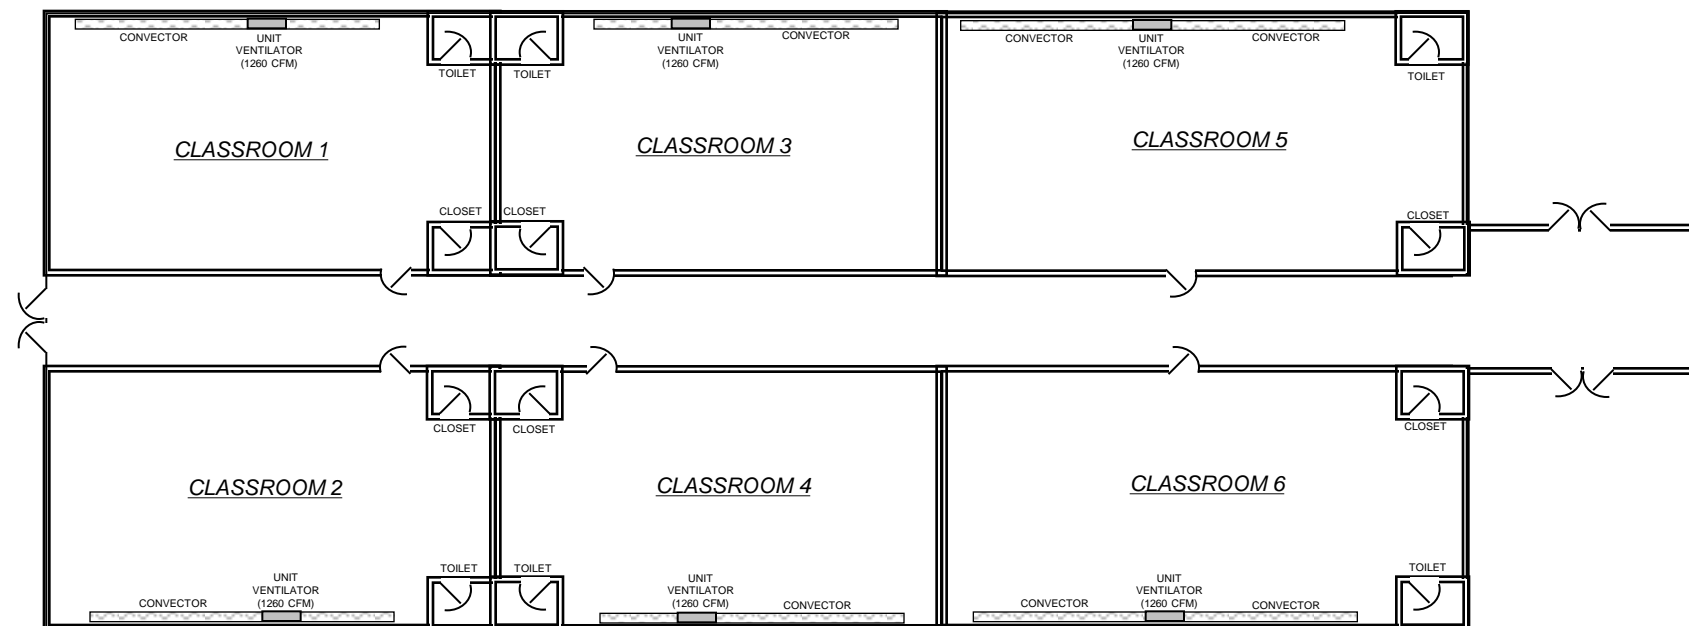

PROJECT DESIGN & MANAGEMENT:

PROJECT:

GEOTHERMAL HVAC UPGRADE
INDIANAPOLIS, IN

EXISTING MECHANICAL PLAN - EAST WING

DATE:

SCALE: 1" = 20'

SHEET: M3

DRN. BY:

CHK. BY:

SHEET NO.: XX of XX